

- Linear RGBW LED luminaire, controlled by DMX programmer. Mounted at ground level.
- Linear RGBW LED luminaire, controlled by DMX programmer. Mounted below cornice.
- Linear RGBW LED luminaire, controlled by DMX programmer. Mounted above cornice.
- ▲ Projector, controlled by DMX programmer. Mounted below cornice.

Draft layout for information purposes and shall not be used for construction.

Be advised that other services may exist that are not shown on this drawing. This drawing should not be taken as definitive or an indication that it is safe to dig.

<small>Drawing title:</small> Draft Lighting Layout		
<small>Project title:</small> Fáilte Ireland Urban Animation ~ Irish Silver Museum		
<small>Client:</small> Waterford City & County Council		
<small>Project number:</small> 22012	<small>Date:</small> 12/5/22	<small>Hard copy approved:</small>
<small>Drawing number:</small> 22012 - 1	<small>Revision:</small> 0	<small>Drawn by:</small> Patrick Redmond
<small>Read in conjunction with associated lighting calculations</small>		
<small>Do not scale from drawing</small>		<small>All dimensions in mm</small>
<small>Document control:</small> TD 09	<small>Version:</small> 1.0	


Redmond Analytical Management Services Ltd.
053 9231112 | info@redmondams.ie | www.redmondams.ie



MSLL ~ Society of Light and Lighting

MILP ~ Institution of Lighting Professionals



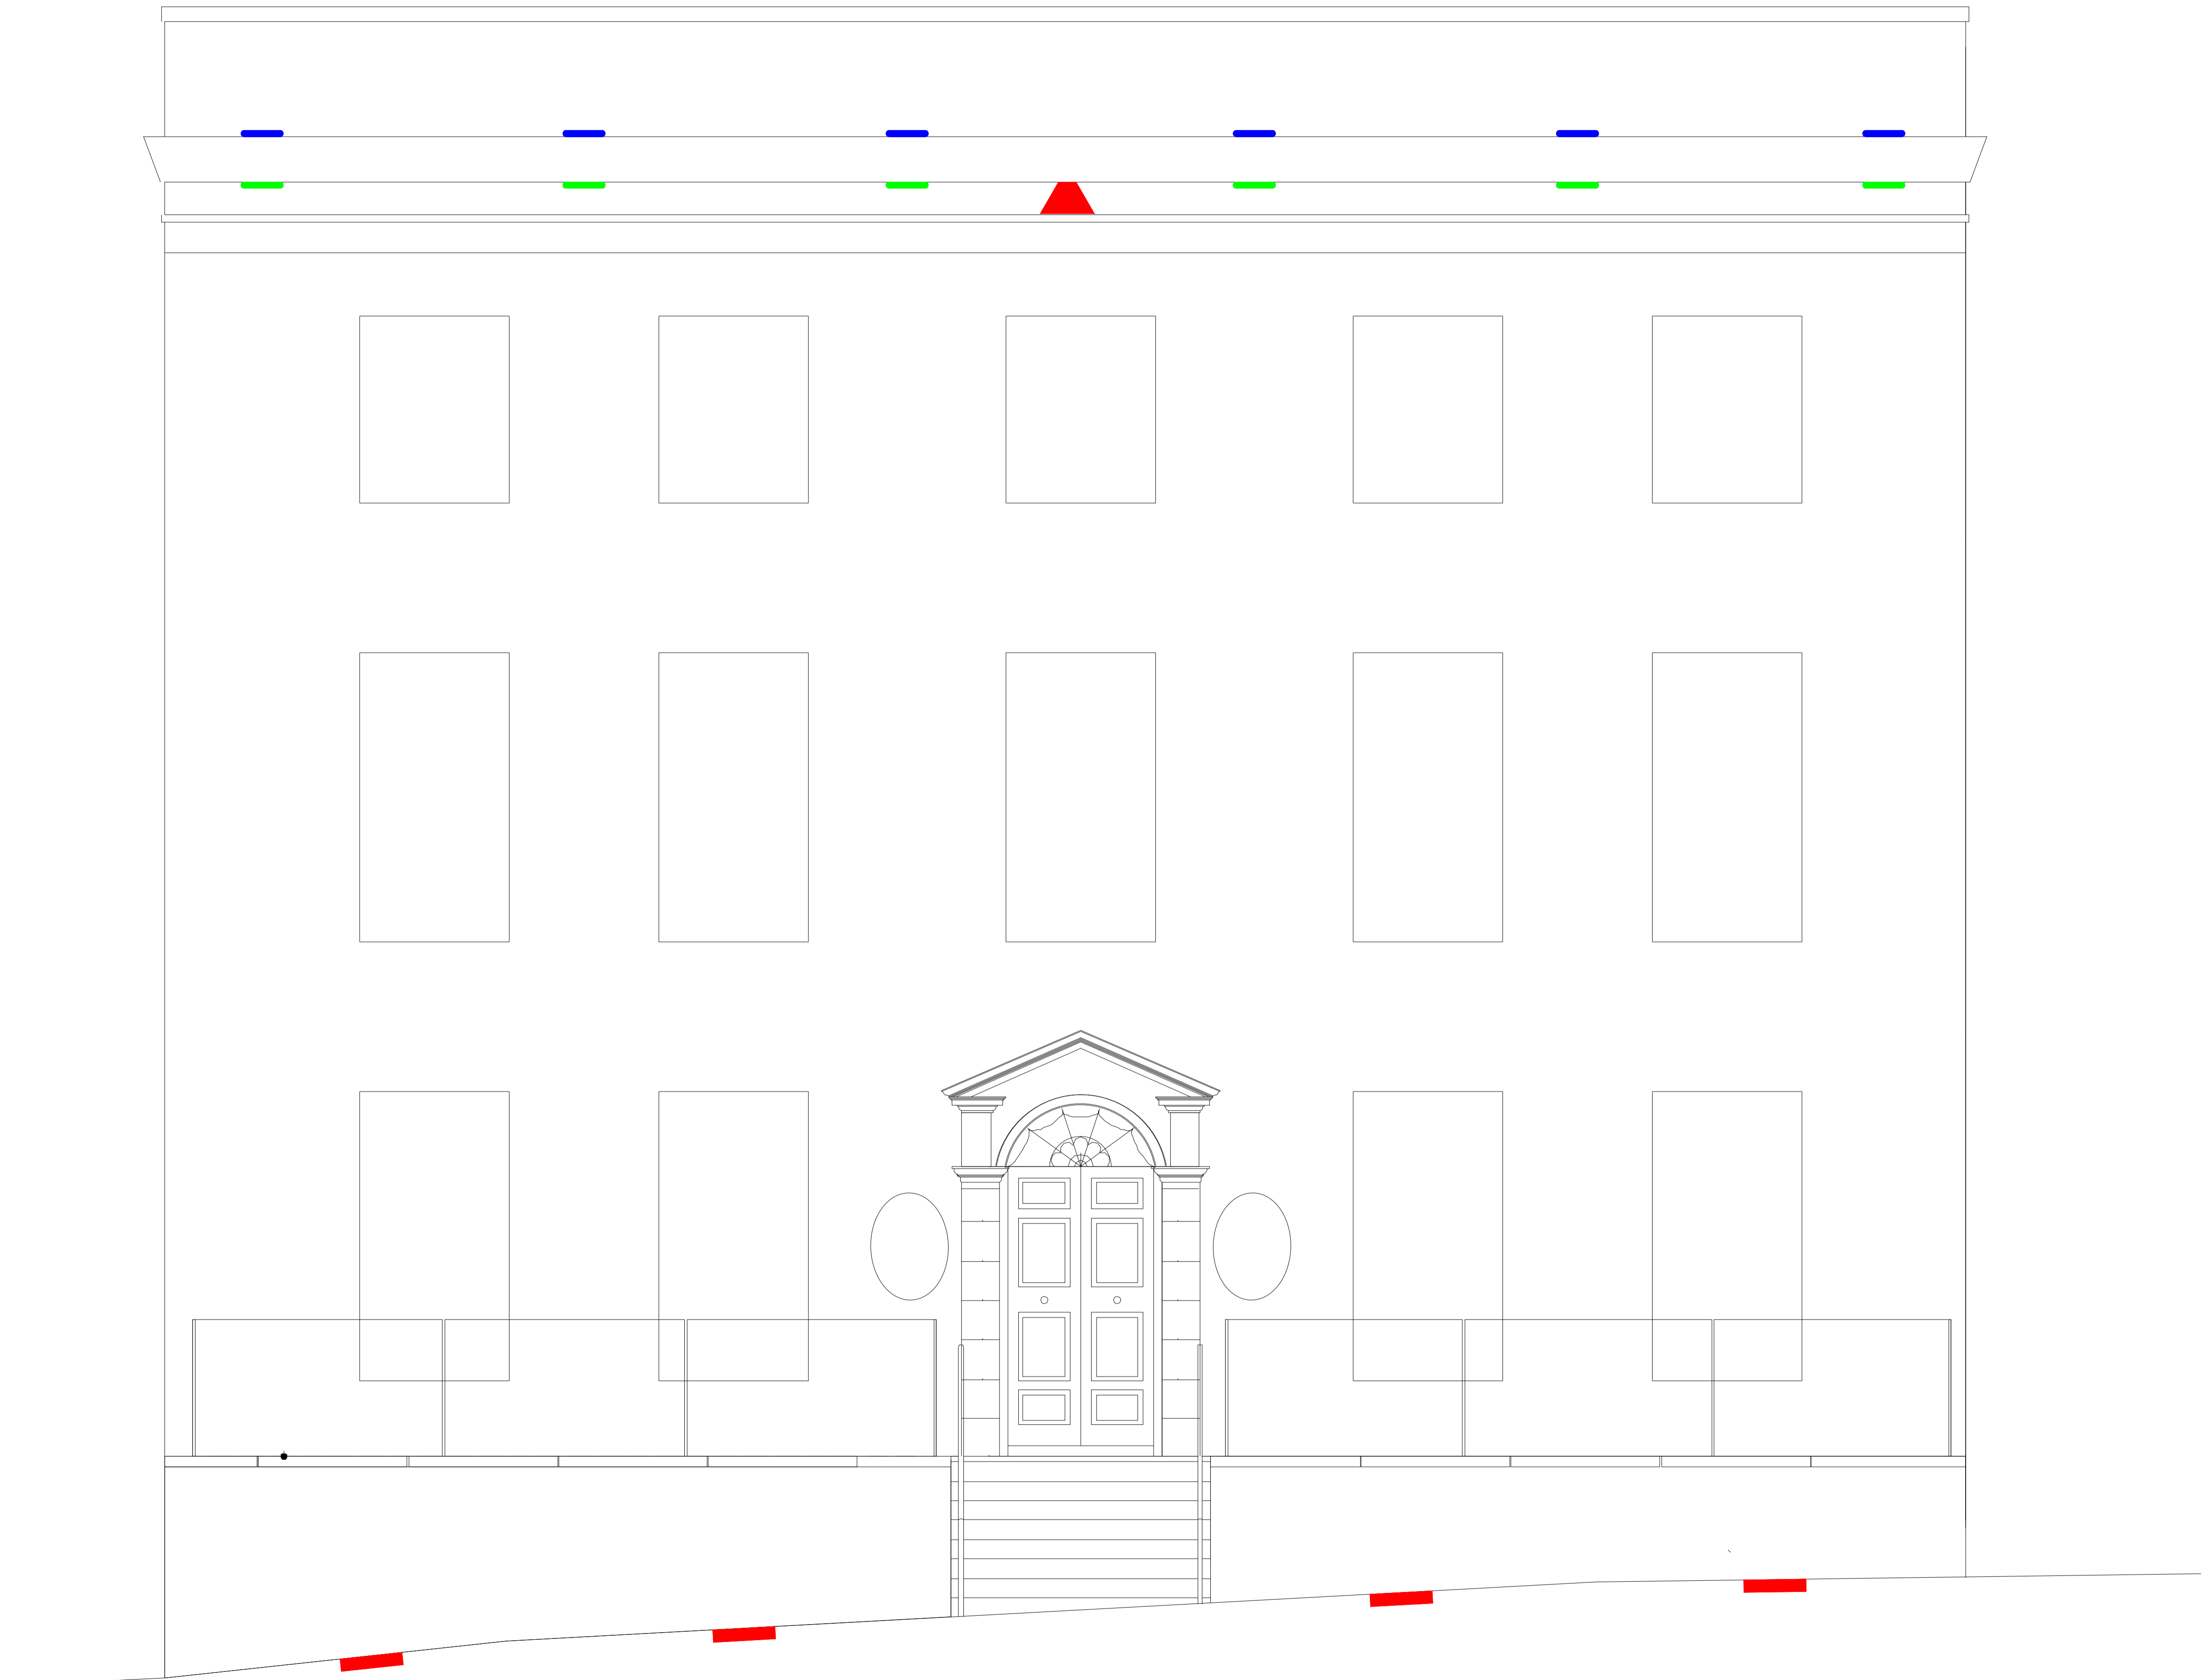

- █ Linear RGBW LED luminaire, controlled by DMX programmer. Mounted at ground level.
- █ Linear RGBW LED luminaire, controlled by DMX programmer. Mounted below cornice.
- █ Linear RGBW LED luminaire, controlled by DMX programmer. Mounted above cornice.
- ▲ Projector, controlled by DMX programmer. Mounted below cornice.

Draft layout for information purposes and shall not be used for construction.

Be advised that other services may exist that are not shown on this drawing. This drawing should not be taken as definitive or an indication that it is safe to dig.

<small>Drawing title:</small> Draft Lighting Layout		
<small>Project title:</small> Fáilte Ireland Urban Animation ~ Irish Silver Museum		
<small>Client:</small> Waterford City & County Council		
<small>Project number:</small> 22012	<small>Date:</small> 12/5/22	<small>Hard copy approved:</small>
<small>Drawing number:</small> 22012 - 2	<small>Revision:</small> 0	<small>Drawn by:</small> Patrick Redmond
<small>Read in conjunction with associated lighting calculations</small>		
<small>Do not scale from drawing</small>		<small>All dimensions in mm</small>
<small>Document control:</small> TD 09	<small>Version:</small> 1.0	

Redmond Analytical Management Services Ltd.
053 9231112 | info@redmondams.ie | www.redmondams.ie



MSLL ~ Society of Light and Lighting

MILP ~ Institution of Lighting Professionals

