

- RGBW LED luminaire, controlled by DMX programmer. Mounted on building.
- ▲ Projector mounted on building, controlled by DMX programmer.
- ▲ Projector mounted on existing street lighting column, controlled by DMX programmer.

Draft layout for information purposes and shall not be used for construction.

Be advised that other services may exist that are not shown on this drawing. This drawing should not be taken as definitive or an indication that it is safe to dig.

<small>Drawing title:</small> Draft Lighting Layout		
<small>Project title:</small> Fáilte Ireland Urban Animation ~ House of Waterford Crystal		
<small>Client:</small> Waterford City & County Council		
<small>Project number:</small> 22011	<small>Date:</small> 12/5/22	<small>Hard copy approved:</small>
<small>Drawing number:</small> 22011 - 1	<small>Revision:</small> 0	<small>Drawn by:</small> Patrick Redmond
<small>Read in conjunction with associated lighting calculations</small>		
<small>Do not scale from drawing</small>		<small>All dimensions in mm</small>
<small>Document control:</small> TD 09	<small>Version:</small> 1.0	


Redmond Analytical Management Services Ltd.
053 9231112 | info@redmondams.ie | www.redmondams.ie



MSLL ~ Society of Light and Lighting

MILP ~ Institution of Lighting Professionals



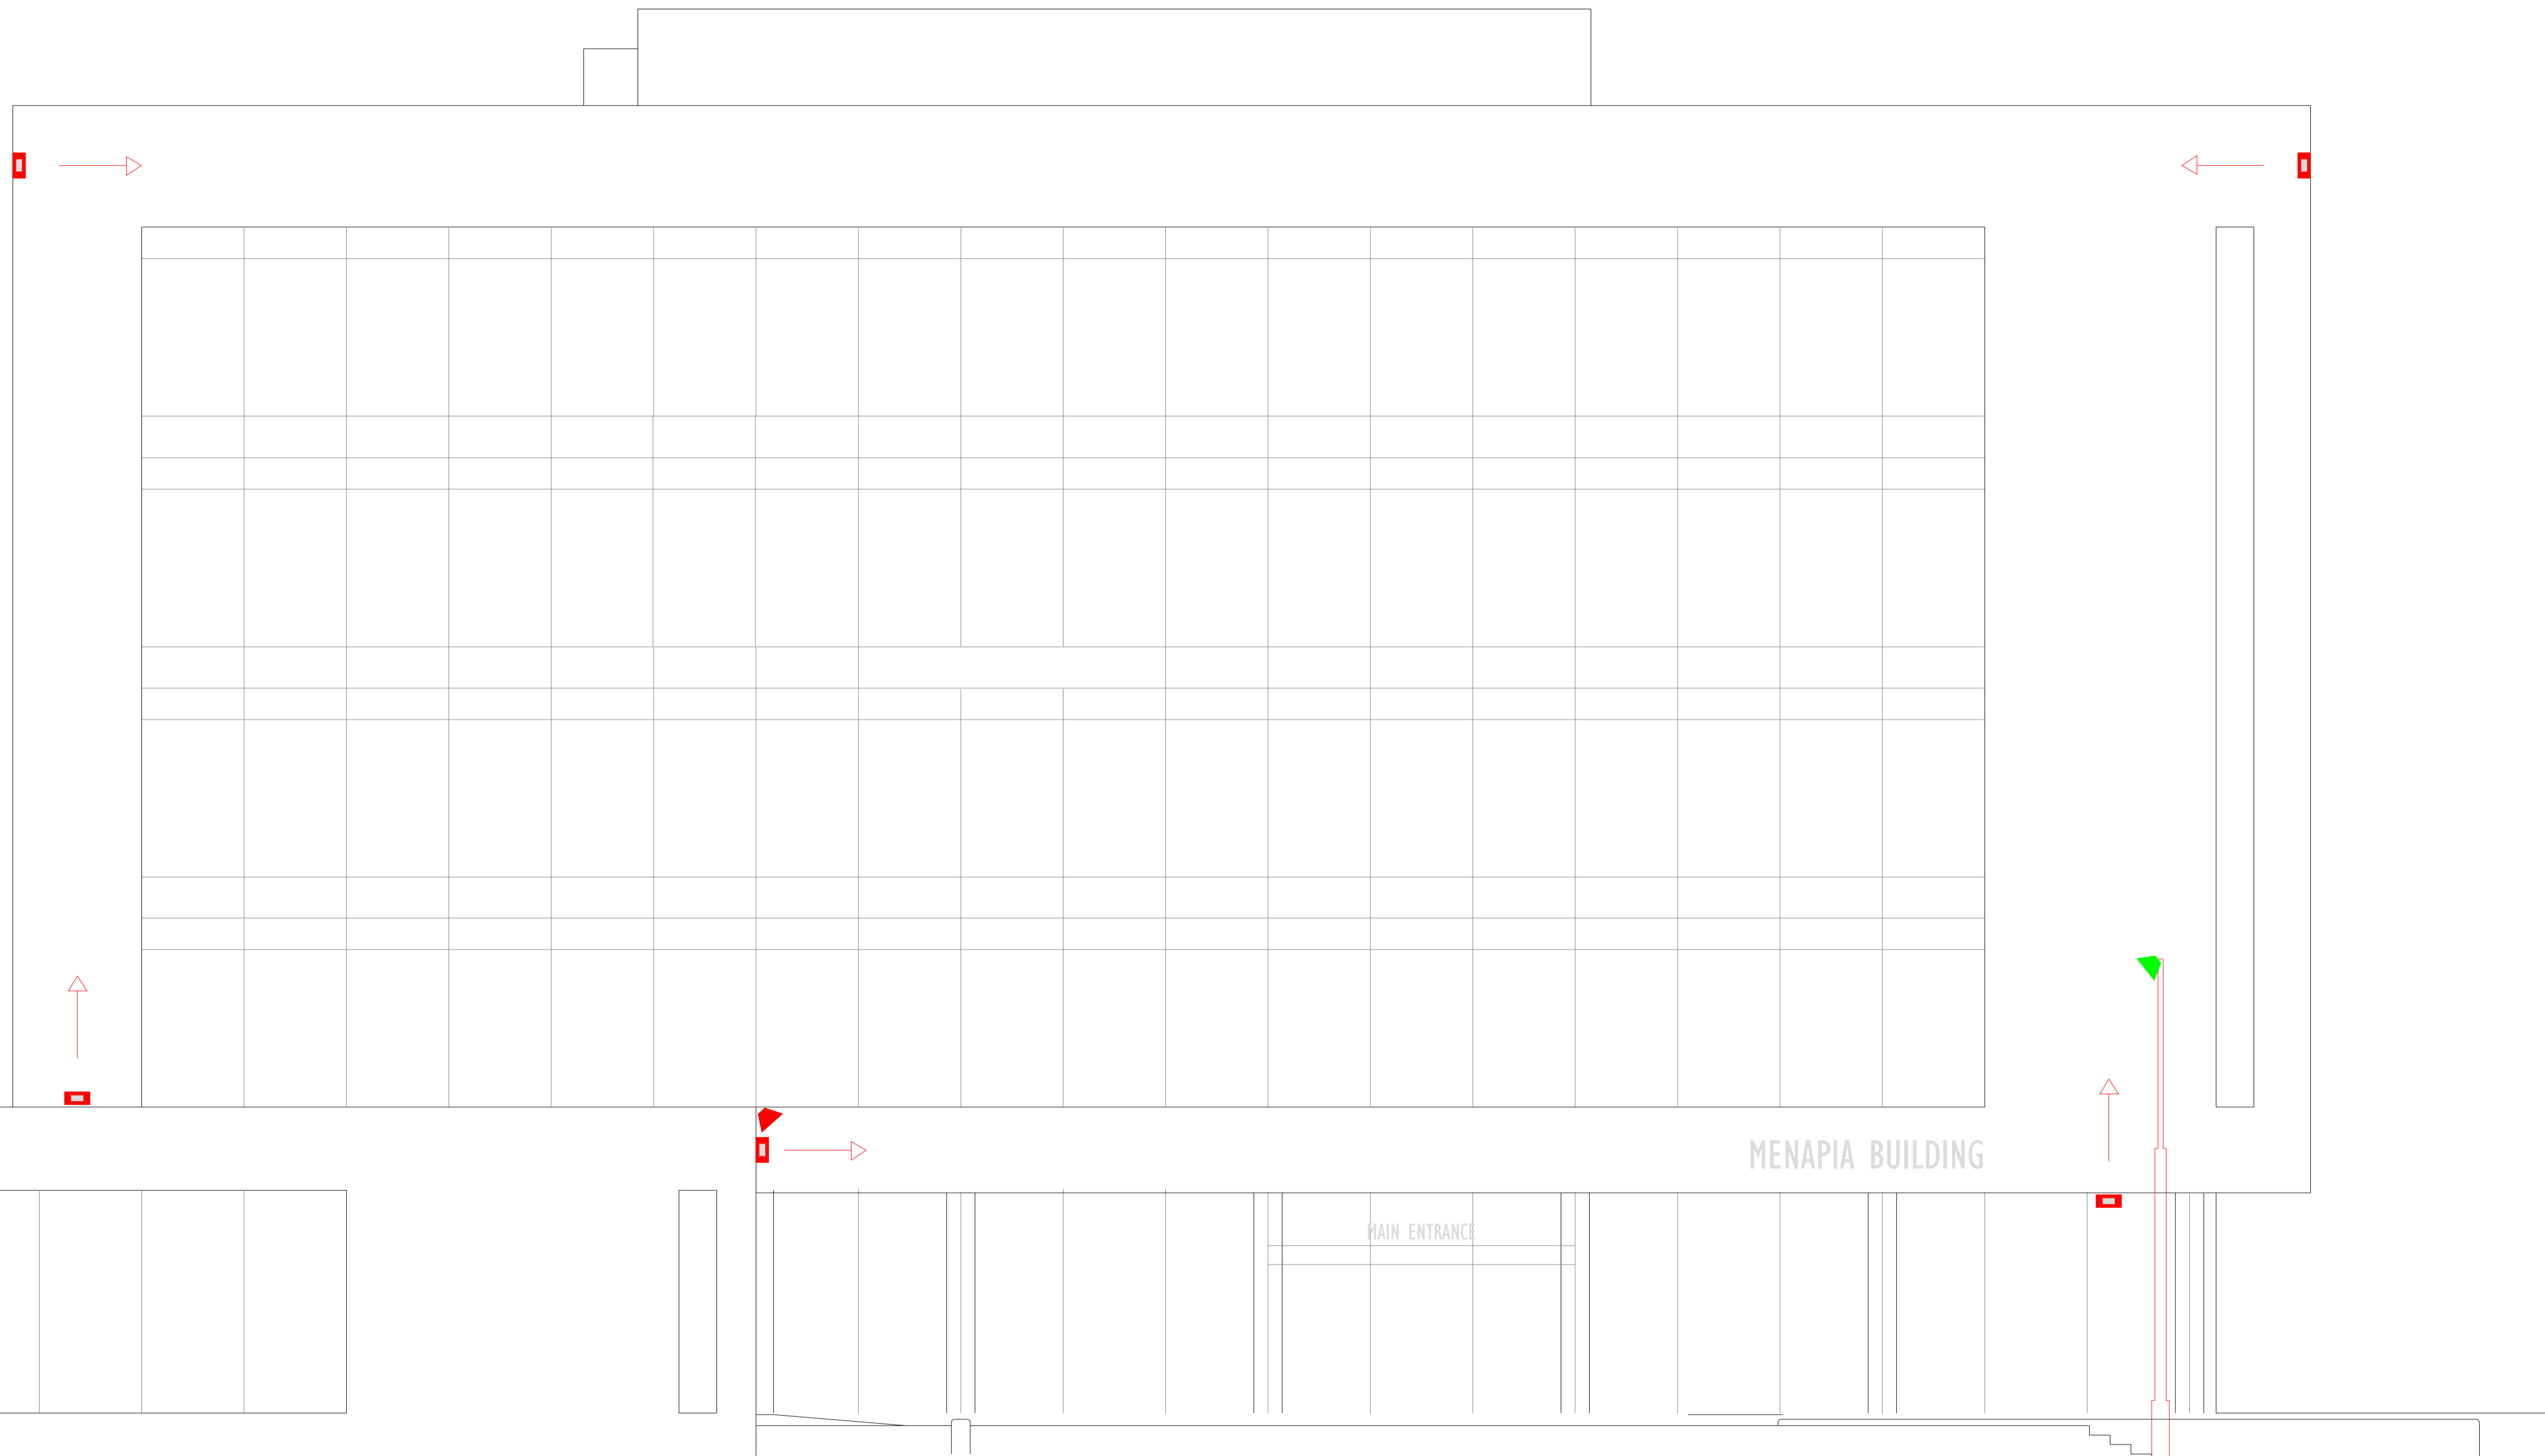

- RGBW LED luminaire, controlled by DMX programmer. Mounted on building.
- ▲ Projector mounted on building, controlled by DMX programmer.
- ▲ Projector mounted on existing street lighting column, controlled by DMX programmer.

Draft layout for information purposes and shall not be used for construction.

Be advised that other services may exist that are not shown on this drawing. This drawing should not be taken as definitive or an indication that it is safe to dig.

Drawing title: Draft Lighting Layout		
Project title: Fáilte Ireland Urban Animation ~ House of Waterford Crystal		
Client: Waterford City & County Council		
Project number: 22011	Date: 12/5/22	Hard copy approved:
Drawing number: 22011 - 2	Revision: 0	Drawn by: Patrick Redmond
Read in conjunction with associated lighting calculations		
Do not scale from drawing		All dimensions in mm
Document control: TD 09	Version: 1.0	

Redmond Analytical Management Services Ltd.
053 9231112 | info@redmondams.ie | www.redmondams.ie

